



ECT-N1000 TUBE DIFFUSER

Please do not scale from this drawing. The information contained in this drawing is copyright and may not be used, in whole or in part, without the express permission of SSI


IF IN DOUBT ASK

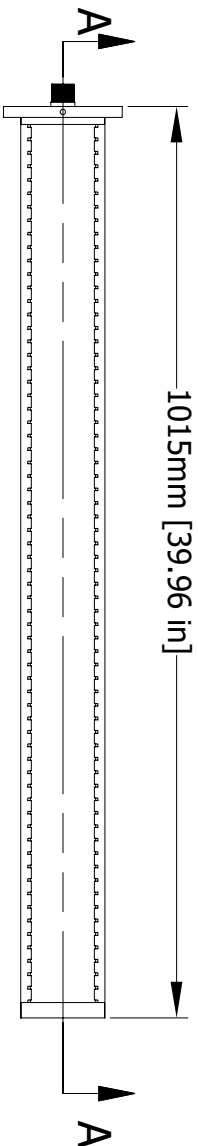

 TOP VIEW



SECTION A-A

 

ISOMETRIC VIEW

1	SUPPORT TUBE PIPE	PP	1		Title: ECT-N1000 TUBE DIFFUSER SSI AERATION 4 Tucker Drive, Poughkeepsie, NY 12603 USA Web: www.ssi-aeration.com Tel: +1-845-454-8171 Fax: +1-845-454-8094
2	MEMBRANE	EPDM/ PTFE	1		
3	3/4" NPT DOUBLE NIPPLE	304SS	1		
Drawn By: M. Kranthi Designed By: Si Kang					
Dwg. No: ECT-N1000					
SCALE: NTS					
PART NO. PART NAME MATERIAL QTY REMARKS					
					SHEET NO.1