
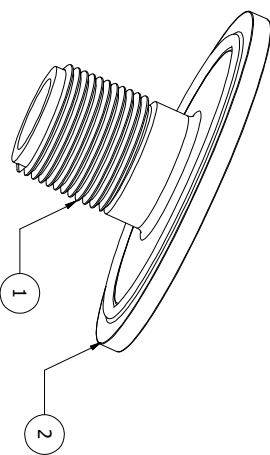
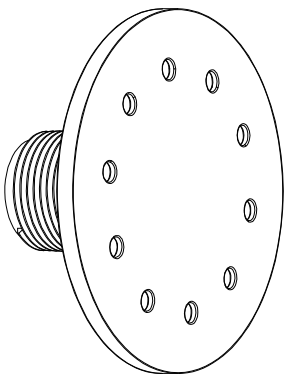


AFC75- COARSE BUBBLE CAP DIFFUSER

Please do not scale from this drawing. The information contained in this drawing is copyright and may not be used, in whole or in part, without the express permission of SSI

IF IN DOUBT ASK

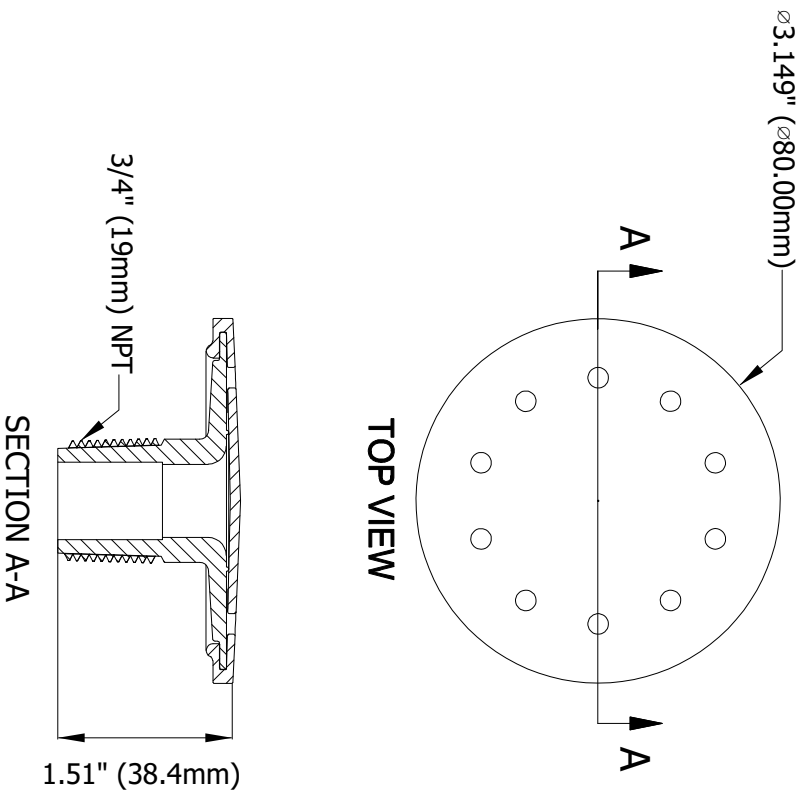

ISOMETRIC VIEWS

1	DIFFUSER BODY	ACETYL	1	Title: AFC-75 COARSE BUBBLE DIFFUSER	SSI AERATION 4 Tucker Drive, Poughkeepsie, NY 12603 USA Web: www.ssi-aeration.com Tel: +1-845-454-8171 Fax: +1-845-454-8094
2	MEMBRANE	EPDM / PTFE	1		
				Designed By: Si Kang	
				Drawn By: M. Kranthi	
				Dwg. No: AFC-75	
PART NO.	PART NAME	MATERIAL	QTY	REMARKS	SCALE: NTS
					SHEET NO.1